


FILE NUMBER: _____
 DRAWING NUMBER: CNxAUD7GHS.PCS
 SCALE: 1" = 1300'
 MINIMUM DEGREE OF ACCURACY: SUBMETER
 PROVEN SOURCE OF ELEVATION: DGPS SURVEY
RTK CENTIMETER SYSTEM

I THE UNDERSIGNED, HEREBY STATE THAT THIS PLAT IS CORRECT TO THE BEST OF MY KNOWLEDGE AND BELIEF AND SHOWS ALL THE INFORMATION REQUIRED BY LAW AND THE REGULATIONS ISSUED AND PRESCRIBED BY THE DEPARTMENT OF ENERGY.

(SIGNED) _____
 STEPHEN D. LOSH, P.S. #674

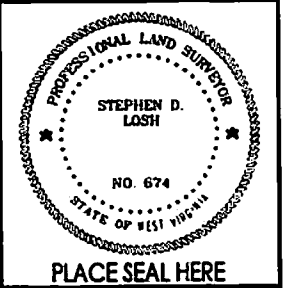

STATE OF WEST VIRGINIA
 DIVISION OF ENVIRONMENTAL PROTECTION
 OFFICE OF OIL AND GAS
 #10 McJUNKIN ROAD
 NITRO, WV 25143-2506

FORM WW-6

WELL TYPE: OIL GAS LIQUID INJECTION WASTE DISPOSAL CBM
 (IF "GAS") PRODUCTION STORAGE DEEP SHALLOW

LOCATION: ELEVATION 1568' WATERSHED ELK CREEK
 DISTRICT PHILIPPI COUNTY BARBOUR
 QUADRANGLE AUDRA LEASE NUMBER SEE ABOVE

SURFACE OWNER BRIAN E. & LISA L. MURPHY ACREAGE 38.00 (13-10)
 OIL & GAS ROYALTY OWNER O. CASTO, ET. AL. UNIT LEASE ACREAGE 1048.63

PROPOSED WORK: DRILL CONVERT DRILL DEEPER REDRILL FRACTURE OR STIMULATE PLUG OFF OLD FORMATION
 PERFORATE NEW FORMATION OTHER PHYSICAL CHANGE (SPECIFY) HORIZONTAL


TARGET FORMATION MARCELLUS PLUG & ABANDON CLEAN OUT & REPLUG
 ESTIMATED DEPTH TVD = 7950' TMD = 16612'

WELL OPERATOR CNX GAS COMPANY LLC DESIGNATED AGENT MATTHEW IMRICH
 ADDRESS P. O. BOX 1248 JANE LEW, WV 26378 ADDRESS P. O. BOX 1248 JANE LEW, WV 26378

LAND SURVEYING SERVICES
 21 CEDAR LANE, BRIDGEPORT, WV 26330
 PHONE: 304-842-2018 OR 842-5762

DATE: AUGUST 26, 2014
 OPERATORS WELL NO.: AUD7GHS
 API WELL NO. 47-001-03350 H6A
 STATE WV COUNTY BARBOUR PERMIT _____

COUNTY NAME _____
 PERMIT _____

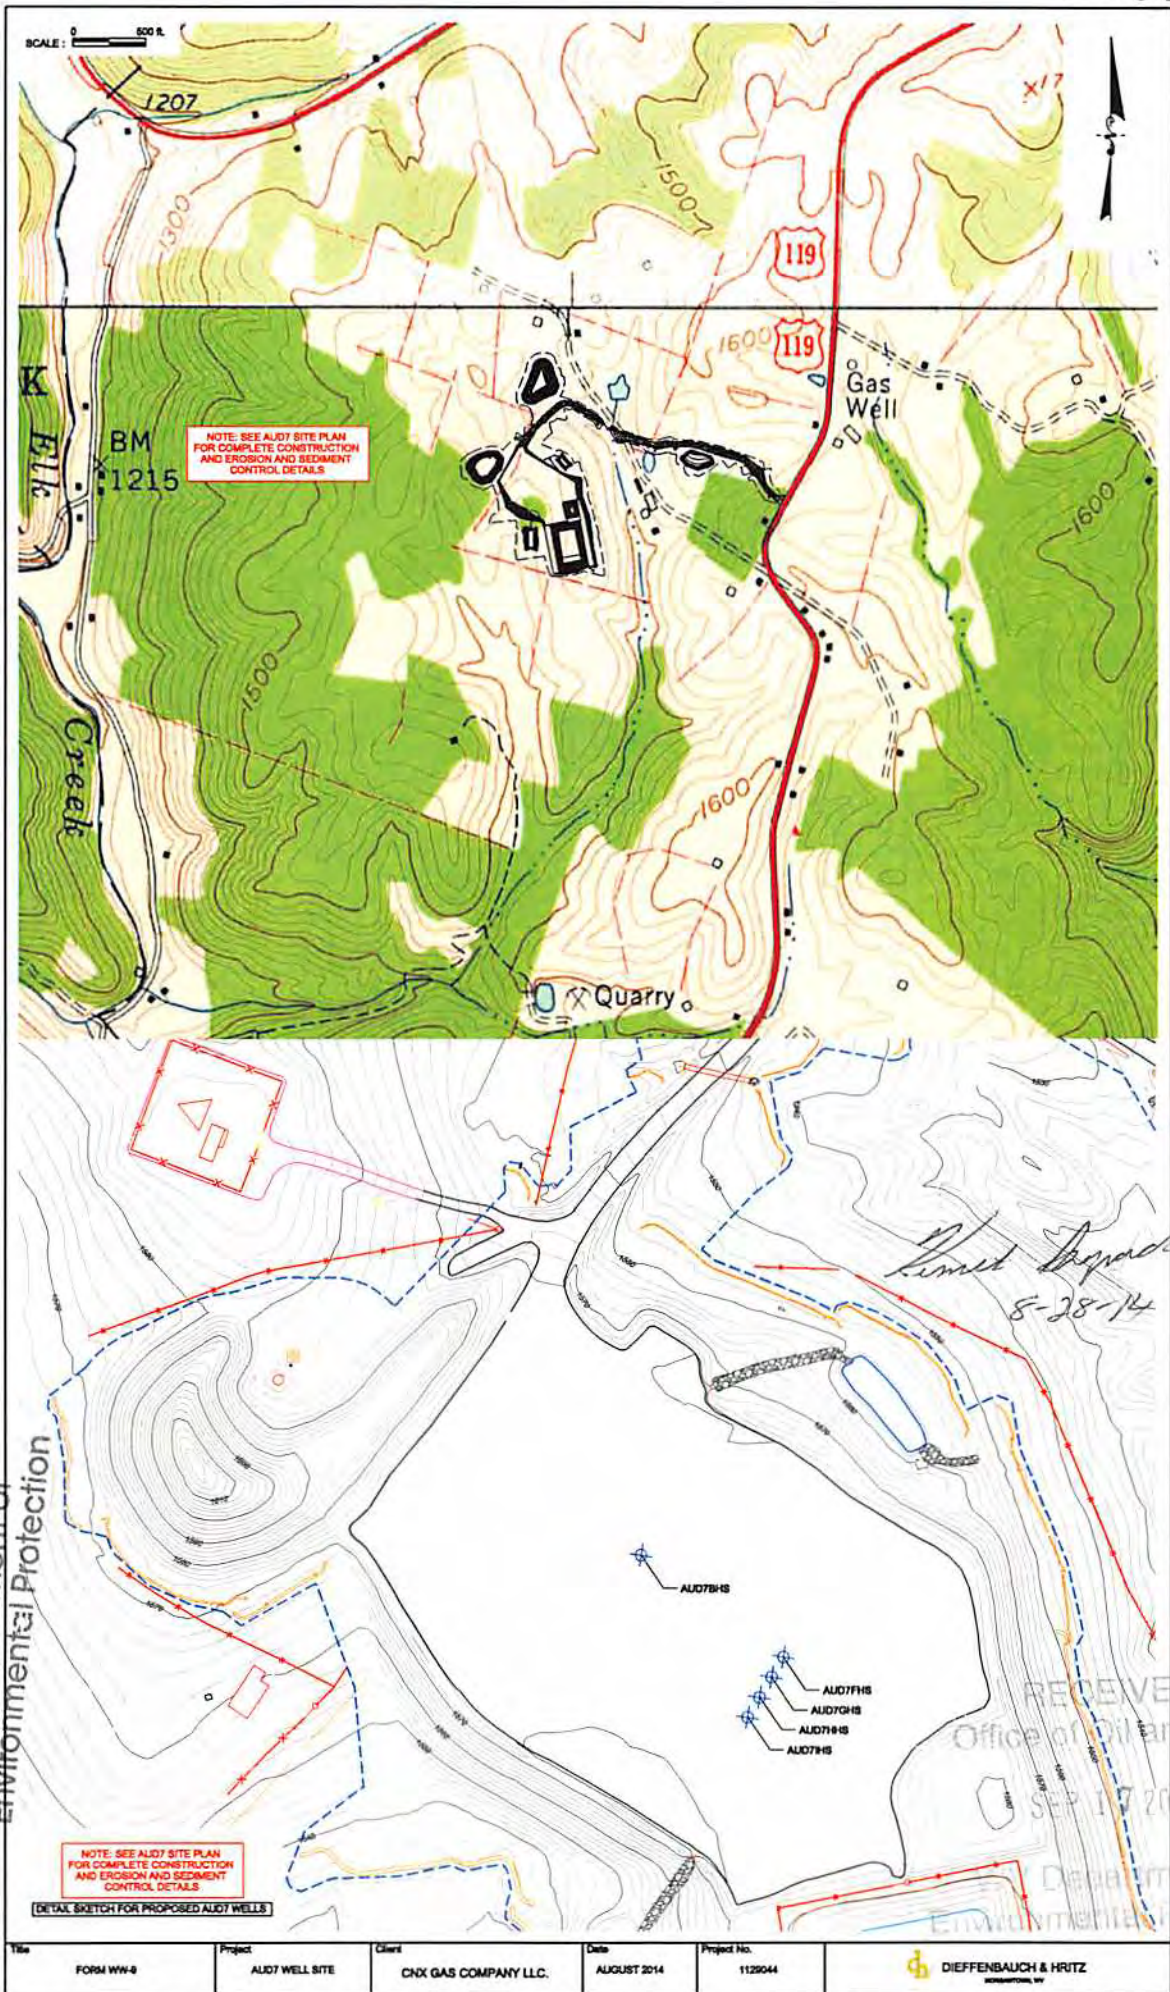

RECEIVED
Office of Oil and Gas

SEP 02 2014

WV Department of
Environmental Protection

*Limit Upgrade
8-28-14*

NOTE: SEE AUD7 SITE PLAN
FOR COMPLETE CONSTRUCTION
AND EROSION AND SEDIMENT
CONTROL DETAILS

DETAIL SKETCH FOR PROPOSED AUD7 WELLS

- AUD7FHS
- AUD7GHS
- AUD7HHS
- AUD7IHS

RECEIVED
Office of Oil and Gas

SEP 17 2014

Department of
Environmental Protection

Title FORM WW-8	Project AUD7 WELL SITE	Client CNX GAS COMPANY LLC.	Date AUGUST 2014	Project No. 1129044	 DIEFFENBAUCH & HRITZ INCORPORATED, WV
--------------------	---------------------------	--------------------------------	---------------------	------------------------	--